
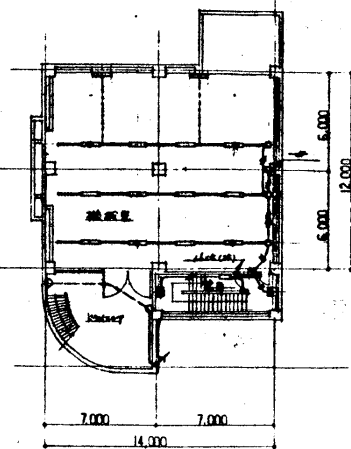


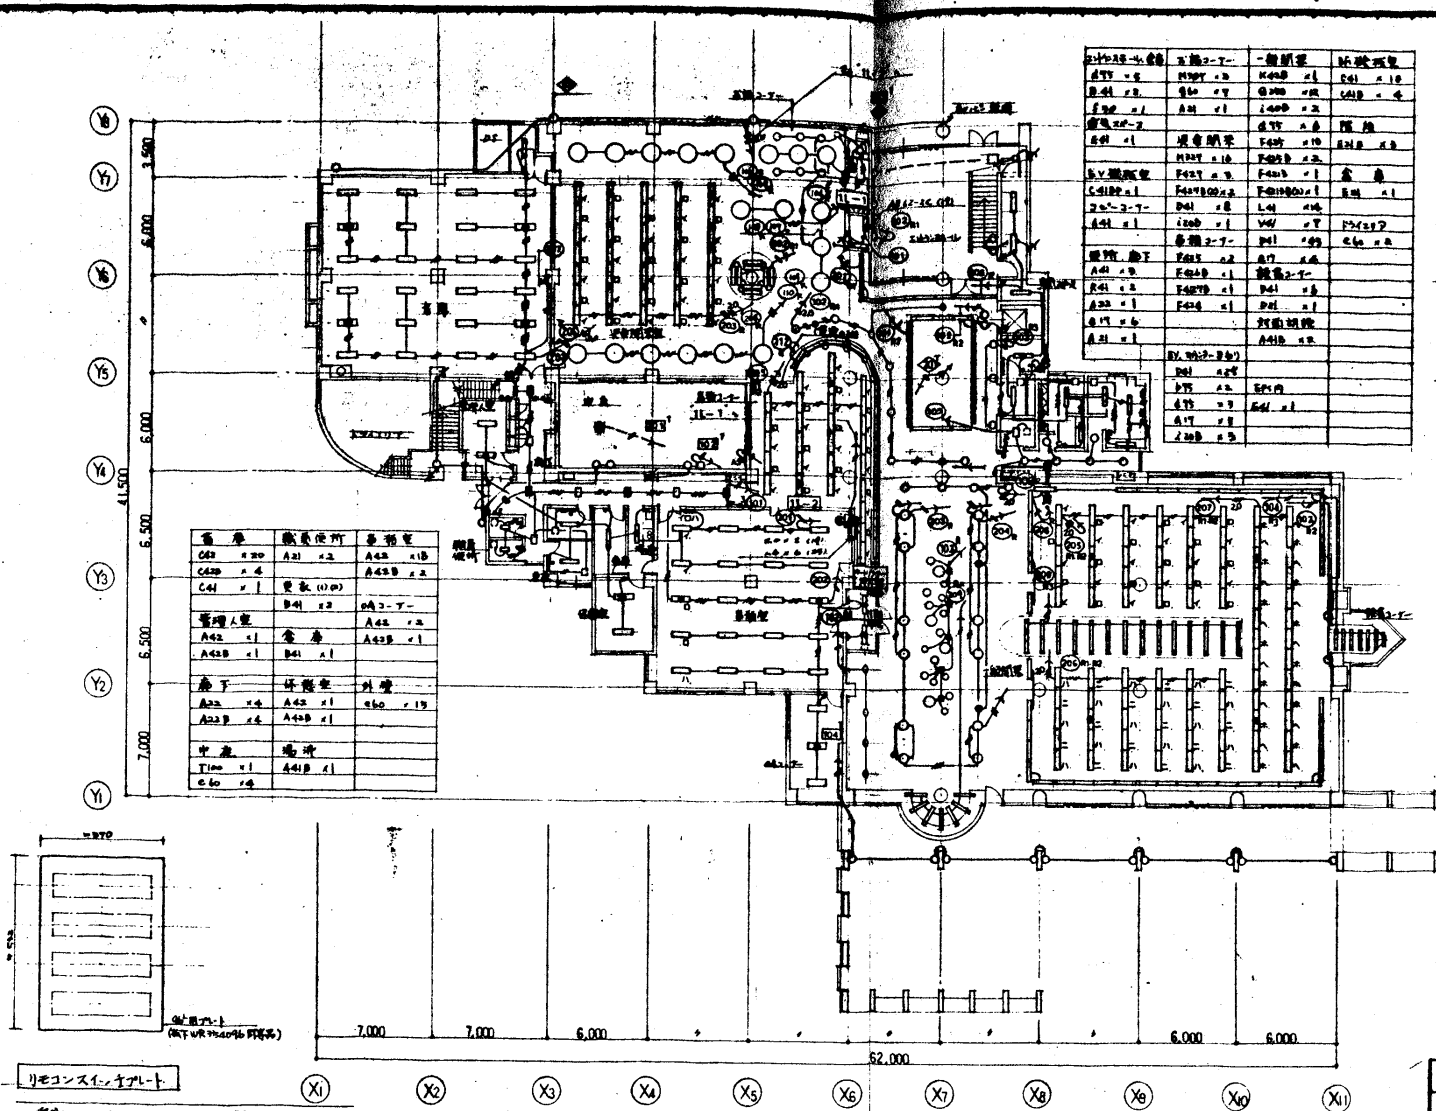

記

1. 図中 特記の配線サイズは下記とする

	A6 # 7 (19)	20	A6 # 7 (19)
3	A6 # 8 (19)	20	A6 # 8 (19)
	A6 # 9 (19)	20	A6 # 9 (19)
	A6 # 10 (19)	20	A6 # 10 (19)
	A6 # 11 (19)	20	A6 # 11 (19)
	A6 # 81 (19)	20	A6 # 81 (19)
	A6 # 82 (19)	20	A6 # 82 (

リモコンスイッチ回路

~~SECRET~~ AB 12-2C (19)

2. モコンスイッチは左下図参照のこと。

小河建築設計事務所



Name 高松市立仮称第二図書館 建設に伴う電気設備工事

Class 電灯設備 1 層平面図 Date. 61. 12

Sheet No. _____

Scale 1:200

Checked by

TAKATSUKI

CITYHALL A. SECTION OF ARCHITECTURE